

NEW CONSTRUCTION
OF
ICE RINK
FOR
THE COUNTY OF UNION

1 Park Drive
Roselle, NJ 07203



20 N. Doughty Avenue
Somerville, NJ 08876
t 908.722.2300
f 908.722.7201

usaarchitects.com

Paul R. Swartz, AIA Susan M. DeHart, AIA
Armand T. Christopher Jr., AIA James McAuliffe, AIA
Peter C. Campisano, AIA Marlene Borruso, AIA
Andrew P. Adornato, AIA

DRAWING LIST

COVER SHEET

A-000 COVER SHEET

CIVIL

1 EXISTING CONDITIONS AND DEMOLITION PLAN
2 LAYOUT AND DIMENSION PLAN
3 GRADING PLAN
4 DRAINAGE AND UTILITY PLAN
5 LANDSCAPING PLAN
6 LANDSCAPING DETAILS
7 LIGHTING PLAN
8 SOIL EROSION & SEDIMENT CONTROL PLAN
9 SOIL EROSION & SEDIMENT CONTROL NOTES & DETAILS
10 CONSTRUCTION DETAILS
11 CONSTRUCTION DETAILS 2
12 STORMWATER MANAGEMENT DETAILS
13 STORMWATER MANAGEMENT DETAILS 2
14 UTILITY DETAILS
15 PLAY AREA DETAILS
16 ADD-ALTERNATE - PLAYGROUND
17 ADD-ALTERNATE PLAYGROUND DETAILS

ARCHITECTURAL

A-001 GENERAL NOTES + BARRIER FREE LEGEND
A-010 BUILDING CODE ANALYSIS - NEW JERSEY
A-011 FIRST FLOOR + MEZZANINE LIFE SAFETY + EGRESS PLAN
A-101 PROPOSED OVERALL FIRST FLOOR PLAN
A-102 PROPOSED PARTIAL FIRST FLOOR PLAN - AREA A
A-103 PROPOSED PARTIAL FIRST FLOOR PLANS - AREAS B + C + MEZZANINE
A-140 ROOF PLAN
A-145 ROOF DETAILS
A-146 ROOF DETAILS
A-160 ENLARGED PLANS + DETAILS
A-180 PLAN DETAILS
A-181 PLAN DETAILS
A-201 PARTIAL REFLECTED CEILING PLAN - AREA A
A-202 PARTIAL REFLECTED CEILING PLANS - AREAS B + C + MEZZANINE
A-210 ENLARGED CEILING PLANS
A-250 CEILING DETAILS
A-300 EXTERIOR ELEVATIONS
A-301 EXTERIOR ELEVATIONS
A-302 EXTERIOR ELEVATIONS
A-303 ENLARGED ELEVATIONS
A-400 BUILDING SECTIONS
A-401 BUILDING SECTIONS
A-402 BUILDING SECTIONS
A-430 WALL SECTIONS
A-431 WALL SECTIONS
A-432 WALL SECTIONS
A-433 WALL SECTIONS
A-434 WALL SECTIONS
A-440 SECTION DETAILS
A-500 VERTICAL CIRCULATION - STAIR + DETAILS
A-600 OPENINGS - SCHEDULES + DETAILS
A-601 EXTERIOR STOREFRONT + CURTAIN WALL GLAZING
A-602 INTERIOR STOREFRONT GLAZING
A-610 STOREFRONT + CURTAIN WALL DETAILS
A-611 STOREFRONT + CURTAIN WALL DETAILS
A-701 INTERIOR ELEVATIONS
A-701 INTERIOR ELEVATIONS
A-750 MILLWORK PLANS + ELEVATIONS
A-751 MILLWORK PLANS + ELEVATIONS + DETAILS
A-800 FIRST FLOOR OVERALL FINISH PLAN + LEGEND
A-801 FIRST FLOOR PARTIAL FINISH PLAN - AREA A
A-802 FIRST FLOOR PARTIAL FINISH PLANS - AREA B + MEZZANINE
A-851 OVERALL FIRST FLOOR + MEZZANINE FURNITURE PLANS

STRUCTURAL

S-001 GENERAL NOTES I
S-002 GENERAL NOTES II
S-100 FOUNDATION PLAN
S-101 MEZZANINE FRAMING PLAN
S-102 LOW ROOF FRAMING PLAN
S-103 HIGH ROOF FRAMING PLAN
S-104 BRACING ELEVATIONS AND DETAILS
S-200 SECTIONS
S-201 ROOF SECTIONS AND DETAILS
S-300 TYPICAL DETAILS I
S-301 TYPICAL DETAILS II
S-302 TYPICAL DETAILS III
S-303 TYPICAL DETAILS IV

FIRE PROTECTION

FP-001 GENERAL NOTES & SYMBOL LIST
FP-100 FIRST FLOOR PLAN AREA A & MEZZANINE PLAN - FIRE PROTECTION
FP-101 FIRST FLOOR PLAN AREA B - FIRE PROTECTION
FP-500 DETAILS

PLUMBING

P-001 GENERAL NOTES & SYMBOL LIST
P-100 FIRST FLOOR PLAN AREA A - SANITARY/VENT
P-101 FIRST FLOOR PLAN AREA B - SANITARY/VENT
P-200 FIRST FLOOR PLAN AREA A - DOMESTIC WATER/GAS
P-201 FIRST FLOOR PLAN AREA B - DOMESTIC WATER/GAS
P-202 MEZZANINE & ENLARGED KITCHEN PLANS - PLUMBING
P-500 DETAILS
P-501 SANITARY RISER DIAGRAMS
P-600 SCHEDULES & DETAILS

REFRIGERATION

R-1000 GENERAL NOTES
R-1001 SCHEDULES
R-1002 REFRIGERATION
R-1003 REFRIGERATION
R-2001 REFRIGERATION
R-2002 REFRIGERATION
R-2100 REFRIGERATION
R-2101 REFRIGERATION
R-3100 REFRIGERATION

MECHANICAL

M-001 GENERAL NOTES & SYMBOL LIST
M-100 FIRST FLOOR PLAN AREA A & MEZZANINE - MECHANICAL
M-101 FIRST FLOOR PLAN AREA B - MECHANICAL
M-500 DETAILS
M-501 SEQUENCES OF OPERATION AND WIRING SCHEMATICS
M-600 SCHEDULES

ELECTRICAL

E-001 GENERAL NOTES & SYMBOL LIST
E-010 SITE PLAN AND DETAILS - ELECTRIC
E-100 FIRST FLOOR PLAN AREA A - POWER
E-101 FIRST FLOOR PLAN AREA B - POWER
E-102 MEZZANINE FLOOR PLAN & ENLARGED KITCHEN PLAN - POWER
E-200 FIRST FLOOR PLAN AREA A - LIGHTING
E-201 FIRST FLOOR PLAN AREA B - LIGHTING
E-202 MEZZANINE PLAN AND BUILDING FACADE - LIGHTING
E-500 DETAILS
E-501 DETAILS
E-502 DETAILS
E-503 DETAILS
E-600 SCHEDULES
E-601 SCHEDULES

FOOD SERVICE

FS.1 FOOD SERVICE EQUIPMENT SCHEDULE & NOTES
FS.2 FOOD SERVICE PLUMBING CONNECTIONS PLAN
FS.3 FOOD SERVICE ELECTRICAL CONNECTIONS PLAN
FS.4 FOOD SERVICE SPECIAL CONDITIONS PLAN
FS.5 FOOD SERVICE EXHAUST HOOD SCHEDULE & PLANS
FS.6 FOOD SERVICE EXHAUST HOOD PLANS & SECTIONS



PROJECT LOCATION:

1 PARK DRIVE
ROSELLE, NJ 07203



1 LOCATION MAP
SCALE: N.T.S.



DESIGN TEAM



USA ARCHITECTS PLANNERS +
INTERIOR DESIGNERS, P.A.
20 NORTH DOUGHTY AVENUE
SOMERVILLE, NJ 08876
908.722.2300



MPP ENGINEERS, LLC
34 WEST MAIN STREET
ALLEN TOWN, NJ 08501
609.489.5511



STRUNK-ALBERT ENGINEERING
804 SEVEN BRIDGES ROAD
EAST STROUDSBURG, PA 08301
570.421.2025



RAYMOND RAYMOND ASSOCIATES
44 ST JOHN STREET
GOSHEN, NY 10924
845.360.5112

UNION COUNTY
BOARD OF COUNTY COMMISSIONERS

Lourdes M. Leon, Chairwoman
Joseph C. Bodek, Vice Chairman
James E. Baker, Jr., Commissioner
Michele S. Delisfort, Commissioner
Sergio Granados, Commissioner
Bette Jane Kowalski, Commissioner
Alexander Mirabella, Commissioner
Kimberly Palmieri-Mouded, Commissioner
Rebecca Williams, Commissioner

CLERK OF THE BOARD
James E. Pellettiere, RMC

COUNTY MANAGER
Edward T. Oatman

DEPARTMENT OF ENGINEERING, PUBLIC WORKS AND
FACILITIES MANAGEMENT
Joseph J. Policay Jr., CPWM
Director, Department of Engineering, Public Works and
Facilities Management

COUNTY ENGINEER
DIVISION OF ENGINEERING
Ricardo Matias, PE, CME, CFM



Andrew P. Adornato, AIA

Registered Architect - New Jersey License No. A116116

USA Architects, Planners and Interior Designers, LTD.
NJ: 21AC00116100 PA: A0001602L DE: 57-000564 MD: 17644
This Document is the property and copyright of USA Architects for the
specified project and shall not be used or reproduced without
authorization.

NEW CONSTRUCTION

OF

ICE RINK

FOR

THE COUNTY OF UNION

1 Park Drive
Roselle, NJ 07203

1 09.13.24 ISSUED FOR BID

No. Date Issue or Revision

Drawing Title

COVER SHEET

Scale AS NOTED USA Project No. R2024.0052



Drawing Date 11.12.2024

Drawing No.

Drawn By DAH

Checked By APA

A-000

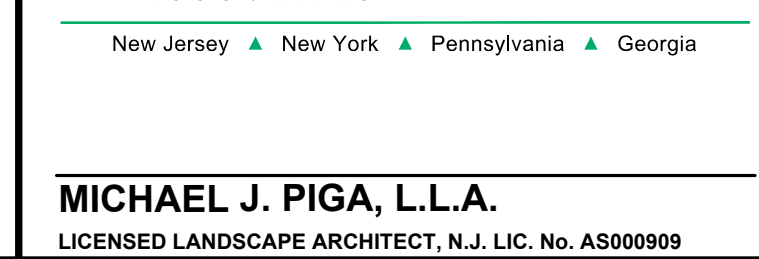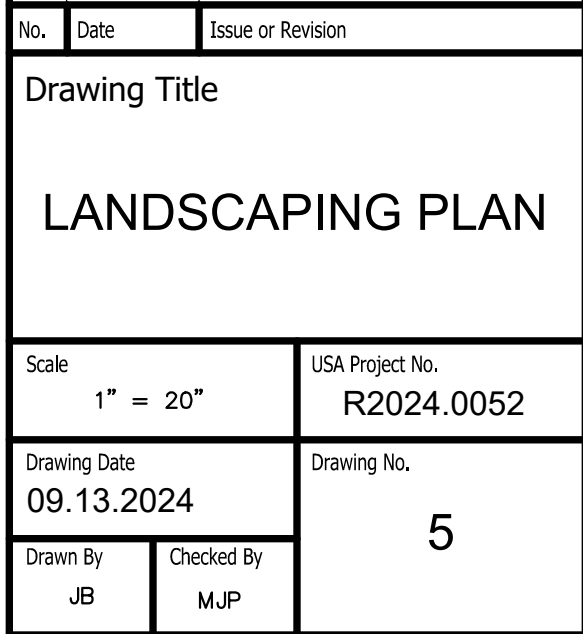

THIS PLAN SHALL BE USED FOR LANDSCAPING PURPOSES ONLY